

GREENFIELD ORGANIX

Conditional Use Permit


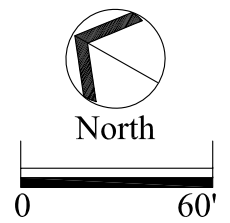


Figure 5

Title: Illustrative Plan
Location: 900 Cherry Avenue, Greenfield
Date: 4/11/16

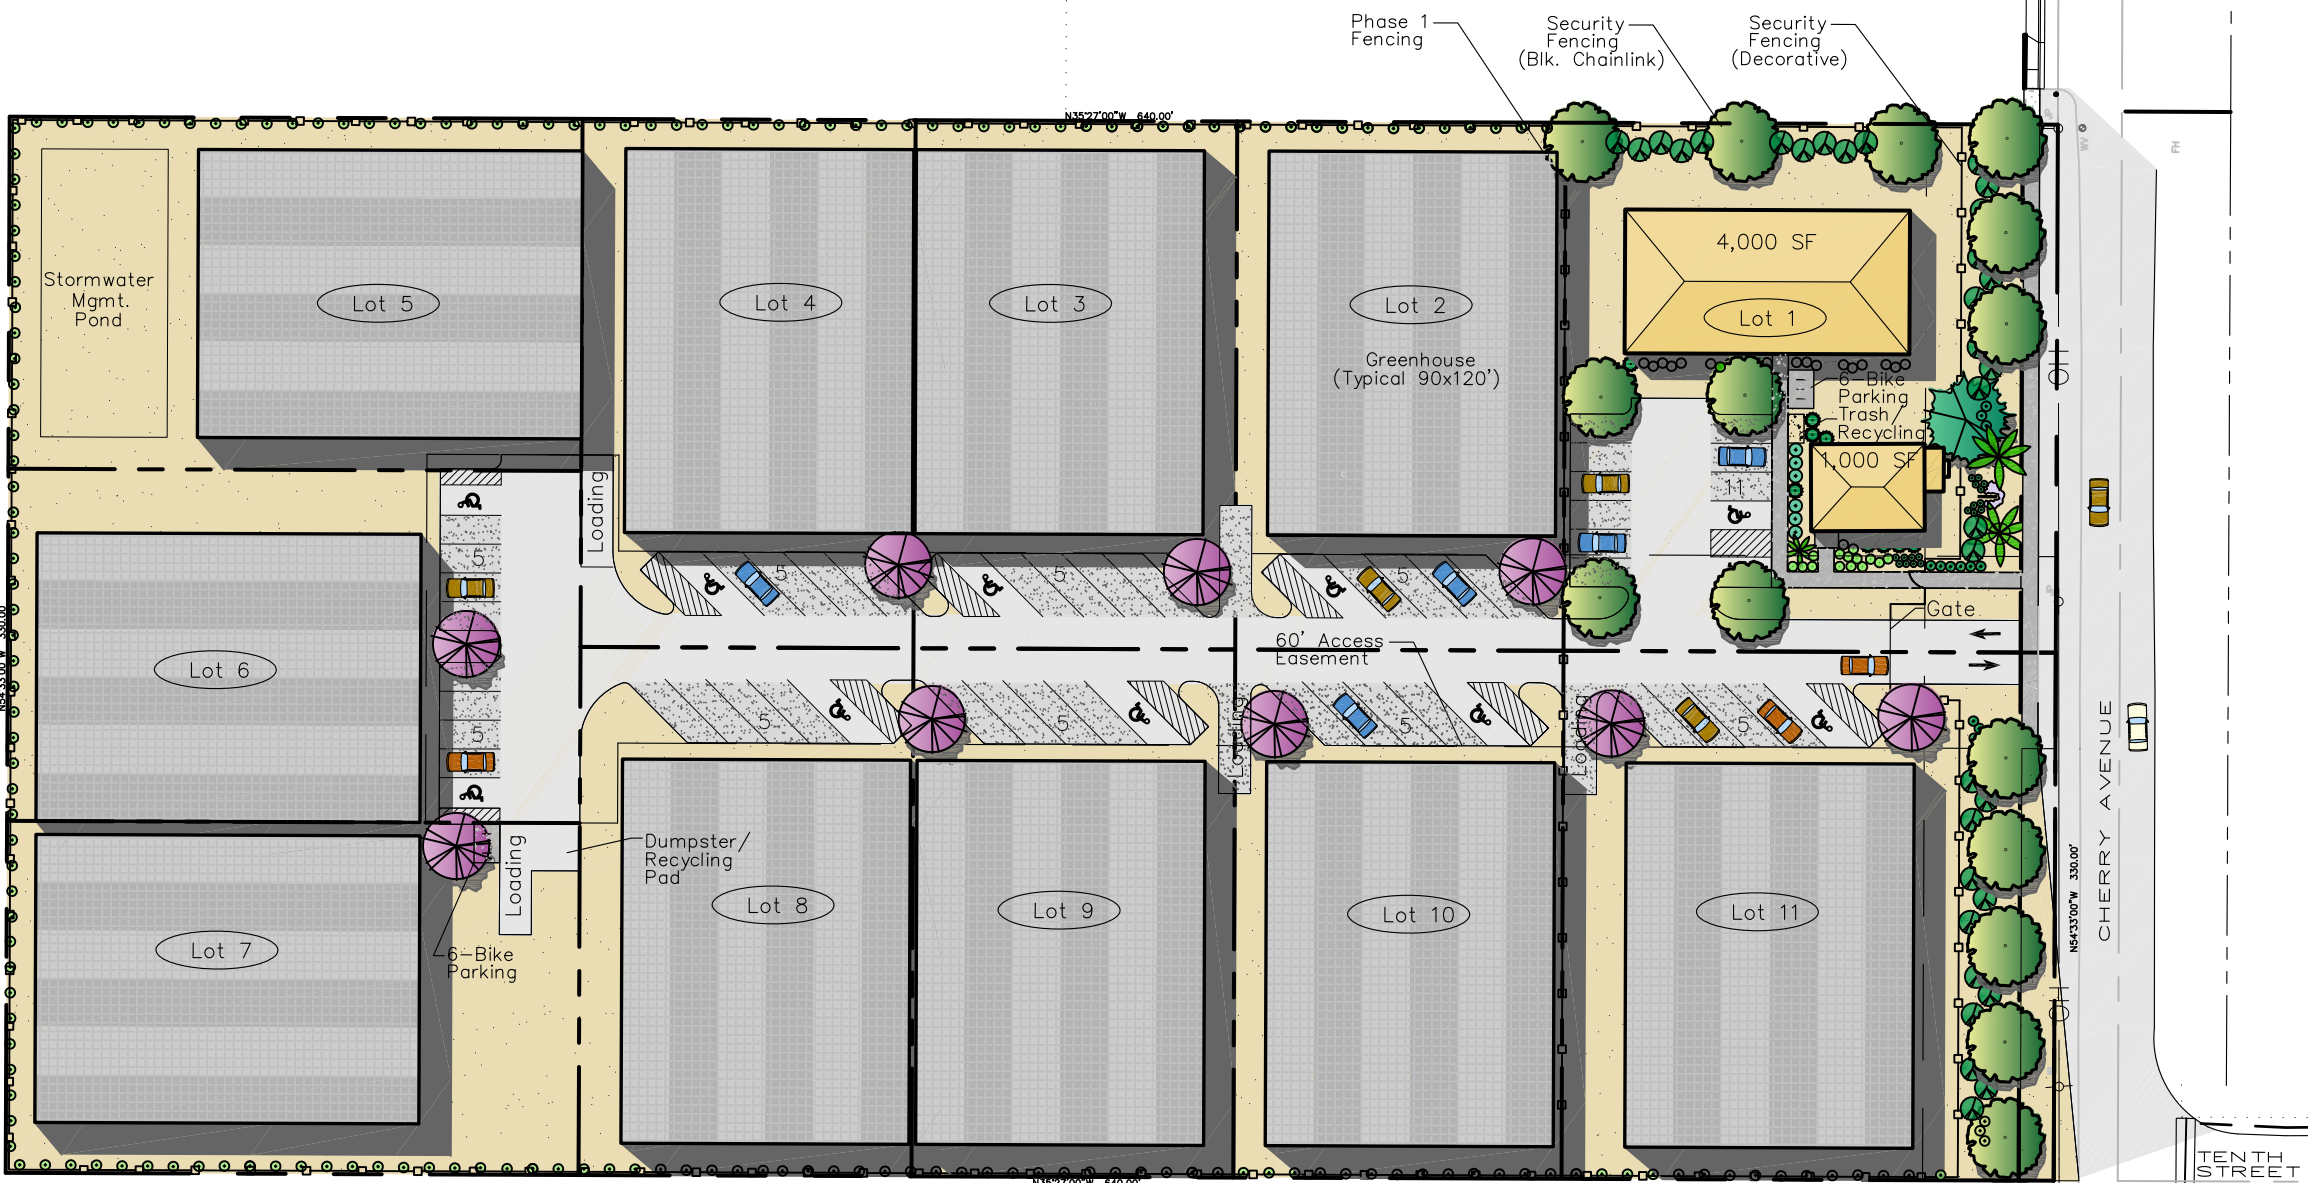

EMC PLANNING GROUP INC.
A LAND USE PLANNING & DESIGN FIRM
Monterey, CA 881.640.1799 www.emcplanning.com

GREENFIELD ORGANIX

Conditional Use Permit

Legend

- Phase I
- Phase II
- Phase III







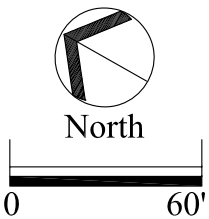


Figure 7

Title: Phasing Plan
Location: 900 Cherry Avenue, Greenfield
Date: 4/11/16

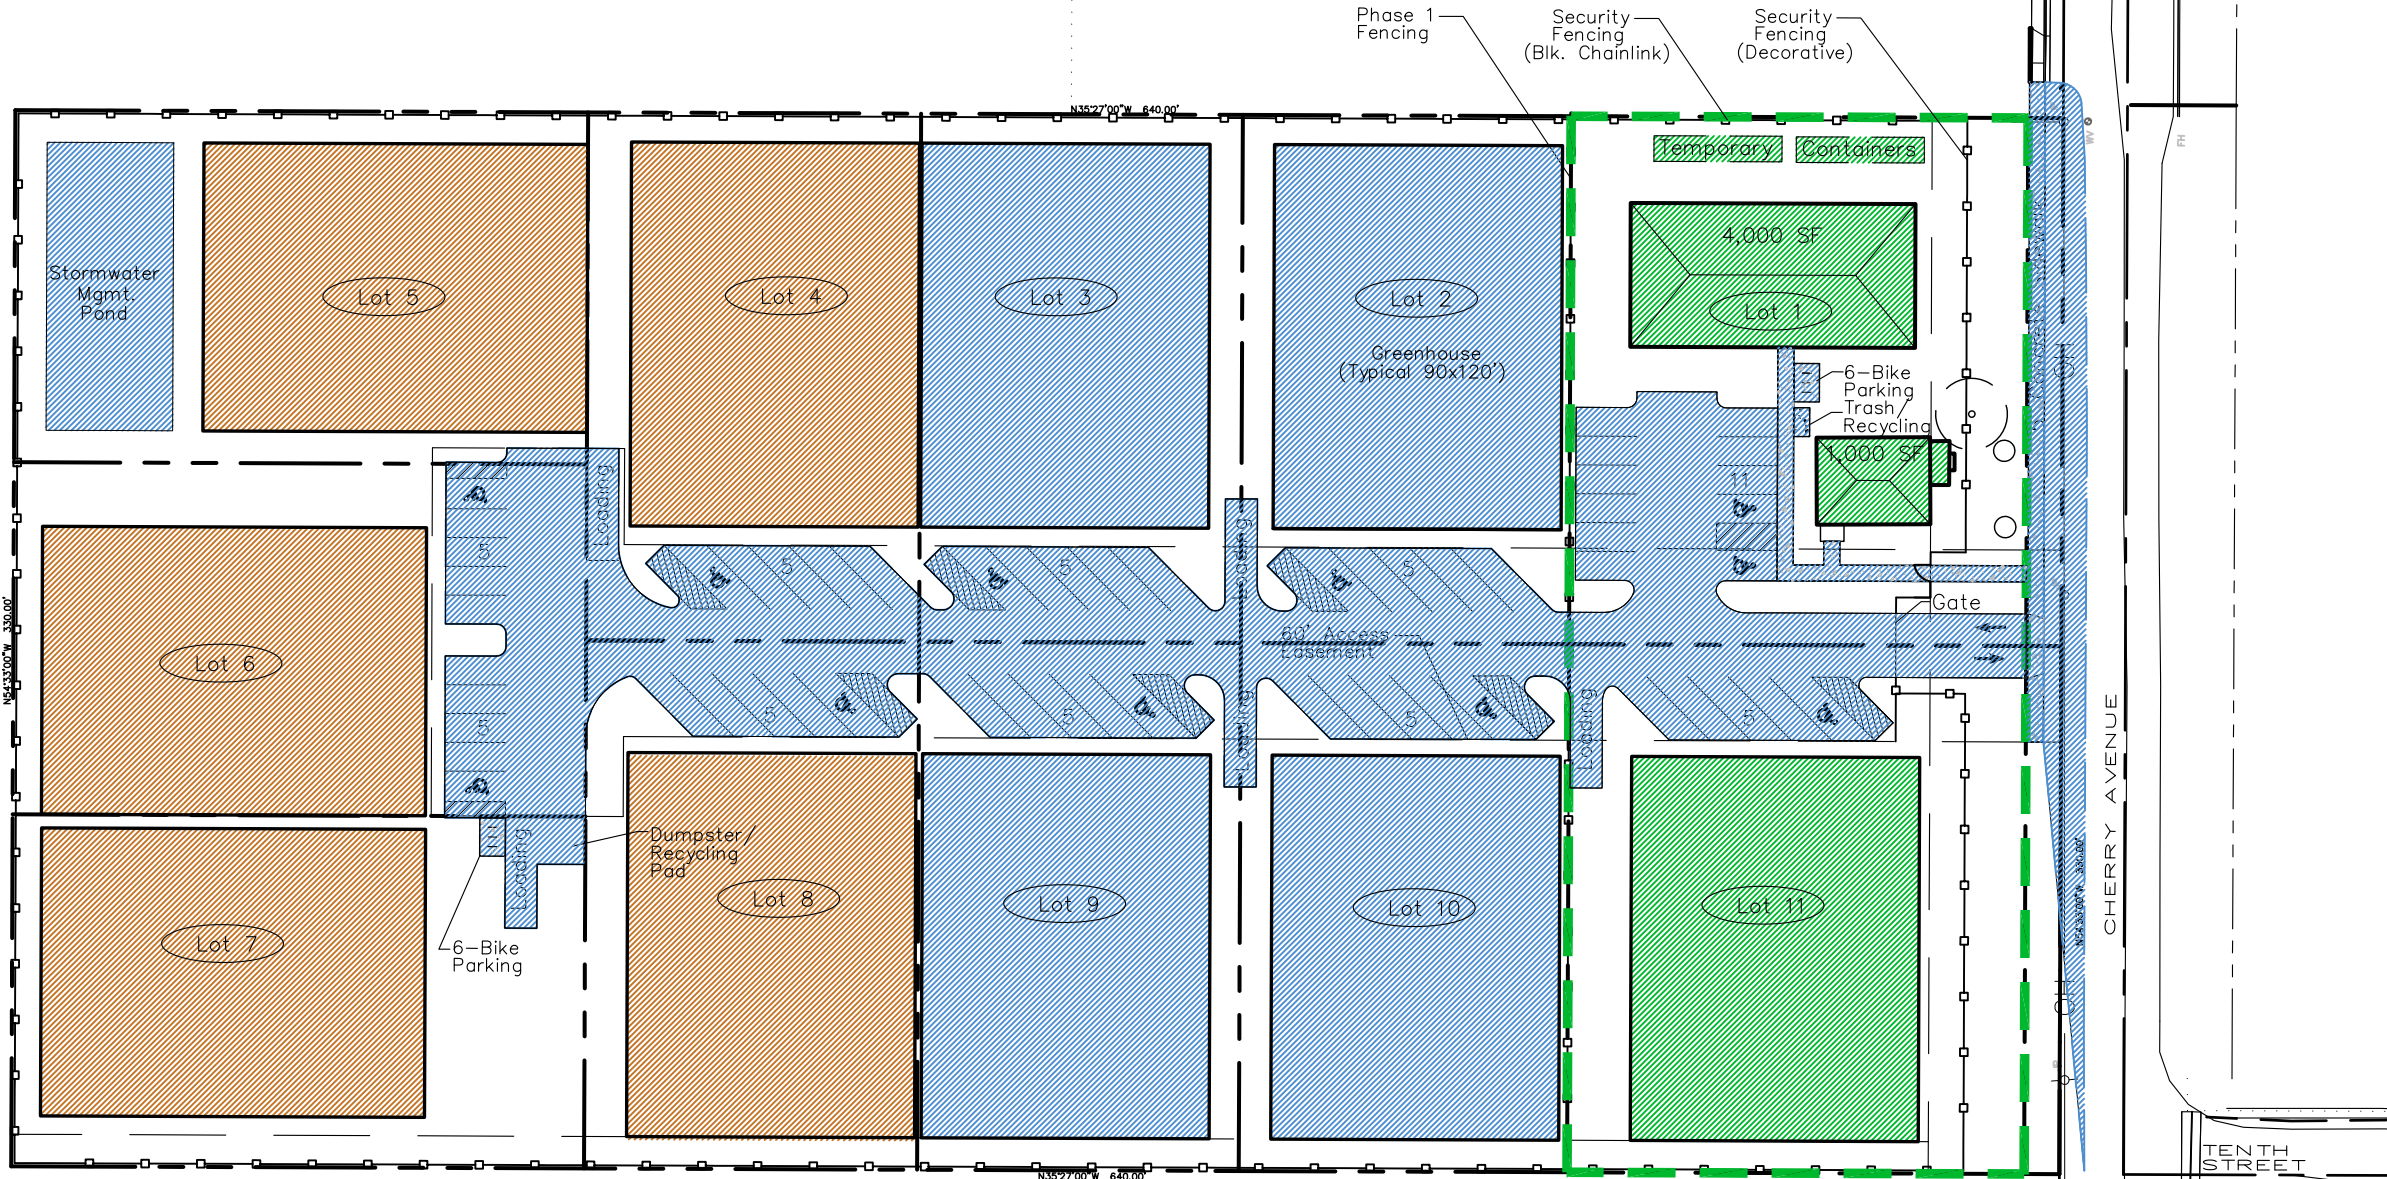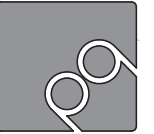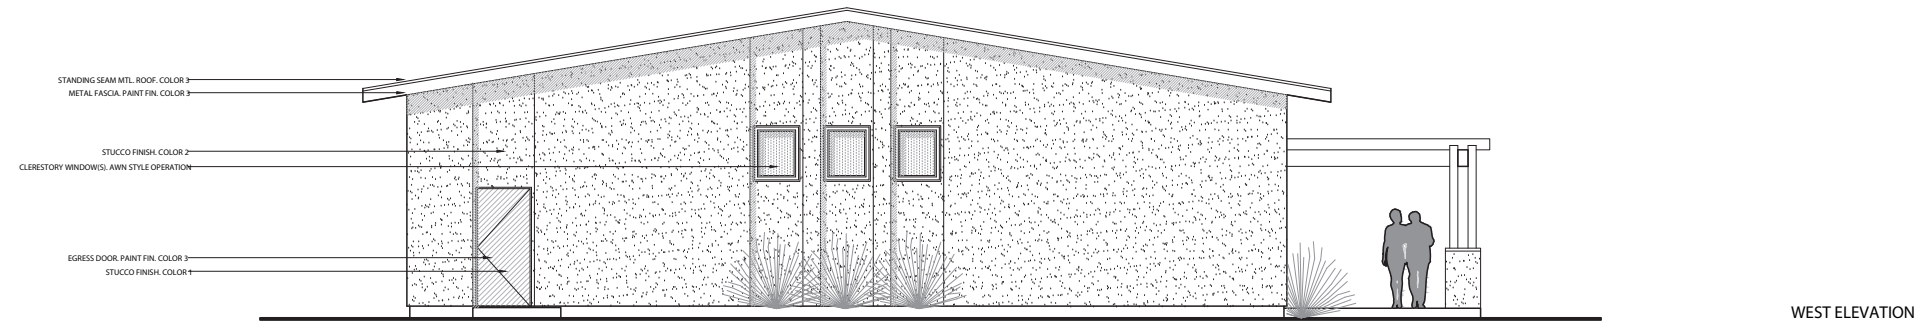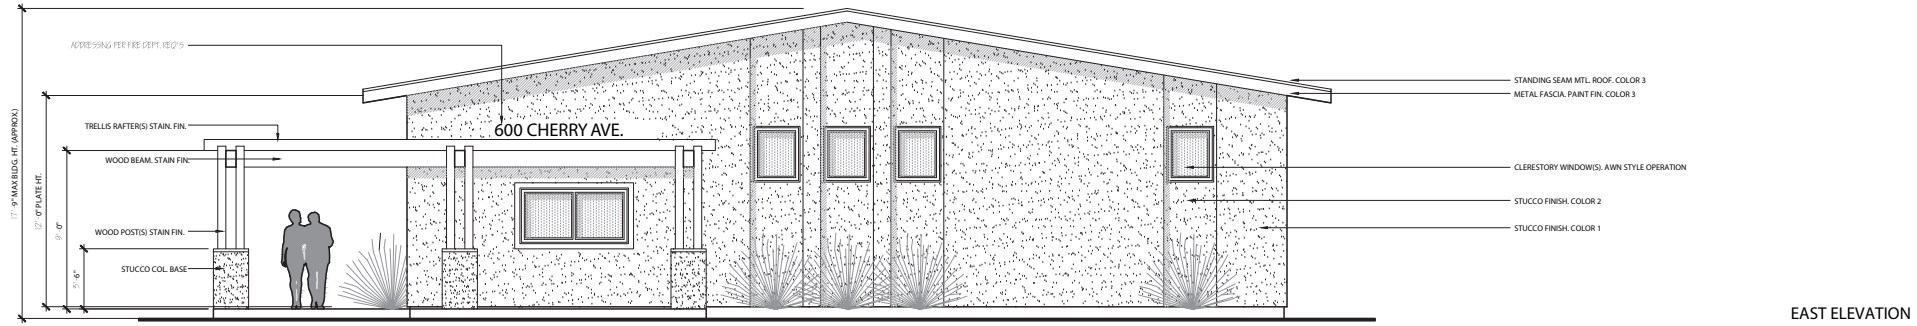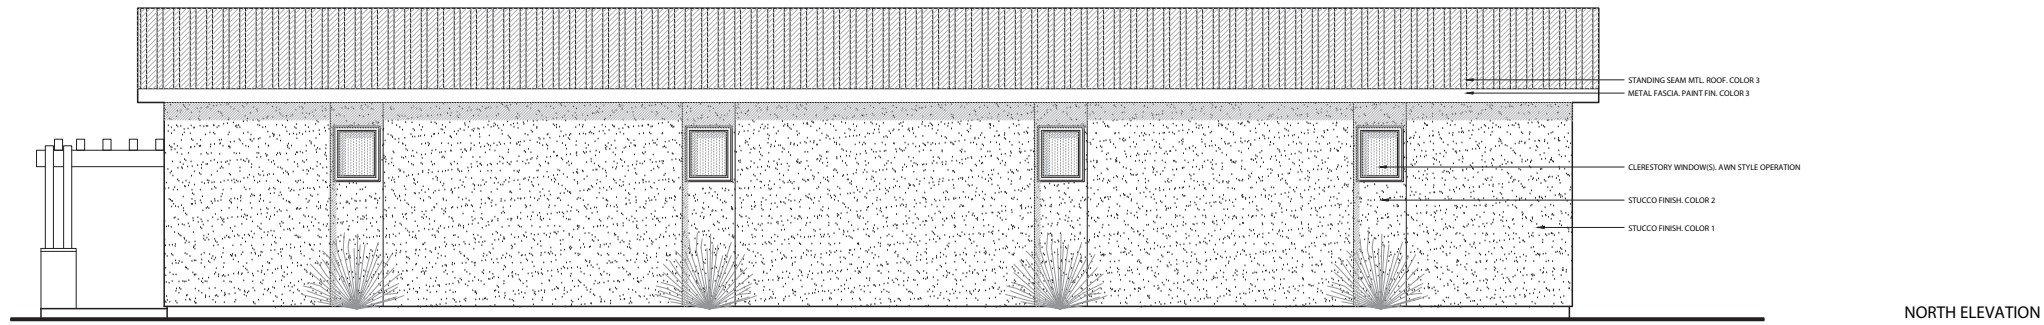

EMC PLANNING GROUP INC.
A LAND USE PLANNING & DESIGN FIRM
Monterey, CA 881.640.1790 www.emcplanning.com

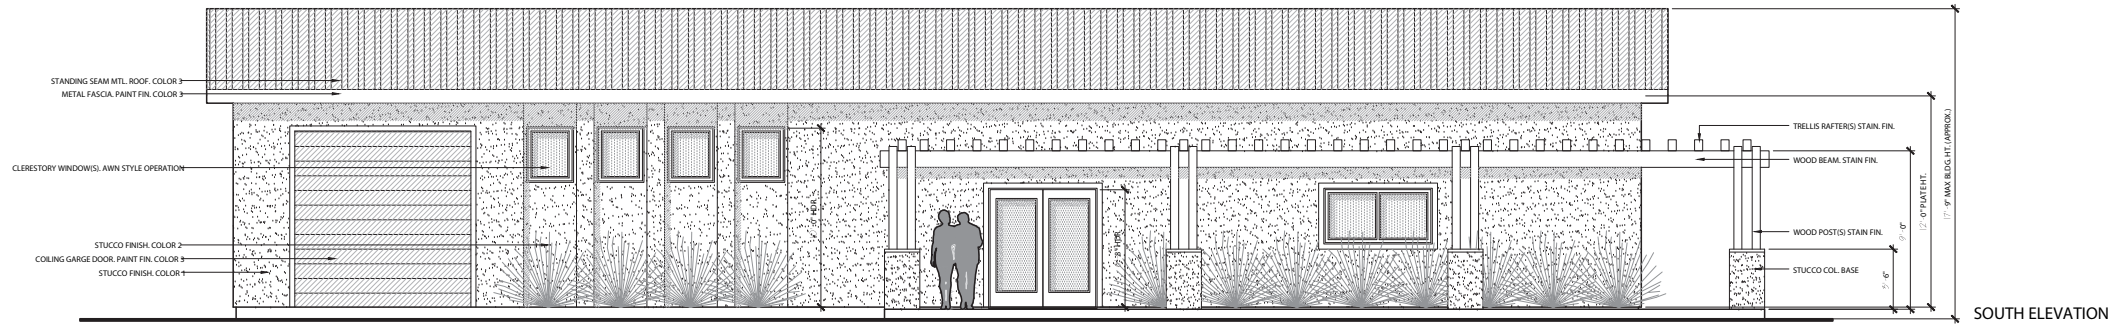

**PQ DESIGN
STUDIO INC**
EIGHT FIFTY WEST UPAS STREET
SAN DIEGO, CALIFORNIA 92103
TELEPHONE: 1-858-527-0888

© 2016 PQ DESIGN STUDIO. ALL RIGHTS RESERVED. THESE PLANS MAY NOT BE REPRODUCED WITHOUT THE PRIOR WRITTEN CONSENT OF PQ DESIGN STUDIO INC. INTELLECTUAL PROPERTY RIGHTS FOR THIS DOCUMENT ARE SOLELY MAINTAINED BY PQ DESIGN STUDIO INC.

GREENFIELD ORGANIX WAREHOUSE FAC.

EXTERIOR ELEVATIONS

PROJECT INFORMATION	
ADDRESS	900 CHERRY AVE
A.P.N.	SEE A1.0
LEGAL	SEE A1.0
ZONING	XXX
BLD. TYP. / OC.	TYPE V B

PLAN REVISIONS & C.O.'S	
XX	XX
XX	XX
XX	XX
XX	XX
XX	XX
XX	XX

BUILDING DEPARTMENT PLAN CHECK TRACKING	
BUILDING PLAN CHECK	XXX
PLANNING PLAN CHECK	XXX
MECHANICAL PLAN CHECK	XXX
PLUMBING PLAN CHECK	XXX
ELECTRICAL PLAN CHECK	XXX
FIRE PLAN CHECK	
LANDSCAPE PLAN CHECK	XXX
DESIGN REVIEW APPROVAL	XXX
SITE DEVELOPMENT PERMIT	XXX
COASTAL DEVELOPMENT	XXX

DRAWN BY	P.R.Q.
DATE	04-01-2016
SCALE	1/4" = 1'-0"
SHEET	A3.0
SHEET	x OF x

Figure 12 Manufacturing Warehouse/Dispensary Facility Elevations



Figure 13

Site Model: View to North

Greenfield Organix Application Package



Figure 14

Site Model: View to Northwest

Greenfield Organix Application Package



Cherry Ave.

Figure 15

Site Model: Street View

Greenfield Organix Application Package

E

M

C